


(ARCHITECTURAL DRAWINGS)

PROJECT MANAGEMENT UNIT
OFFICE

PAKISTAN DIGITAL CITY, HARIPUR
KHYBER PAKHTUNKHWA INFORMATION TECHNOLOGY BOARD (KPITB)
GOVERNMENT OF KHYBER PAKHTUNKHWA

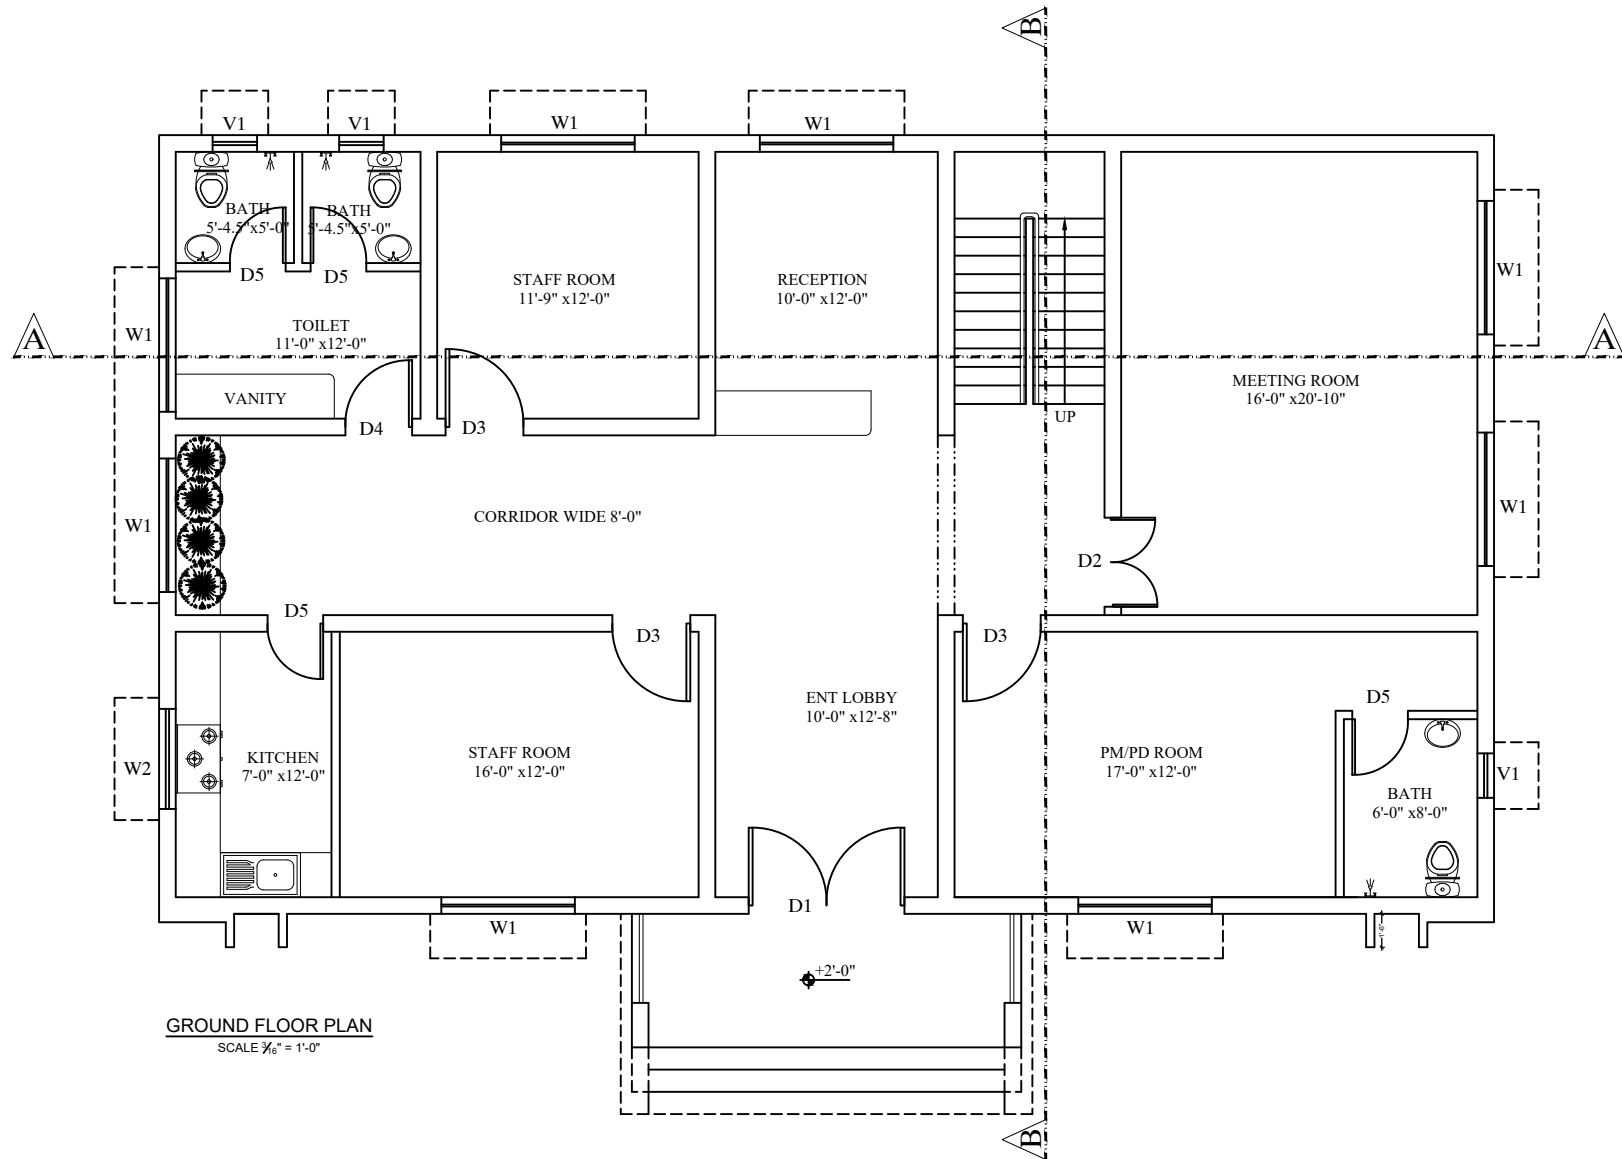

PAK
CONSULTING ENGINEERS

ENGINEER:-
PAK CONSULTING ENGINEERS
CHIB PLAZA COMMERCIAL AREA
CHAKLALA SCHEME III RAWALPINDI
Email: pakconsultingengineers@gmail.com

DRAWN BY
GHULAM MURTAZA

APPROVED BY
BABAR TANWIR

PROJECT:-
PMU, PAKISTAN DIGITAL
CITY HARIPUR KP


DATE: _____
SCALE: N.T.S.

DRAWING NO.:-
01

TITLE:-
GROUND FLOOR PLAN

SUB TITLE:-
LAYOUT PLAN

REV No.	DATE	REVISIONS
1		
2		
3		
4		
5		

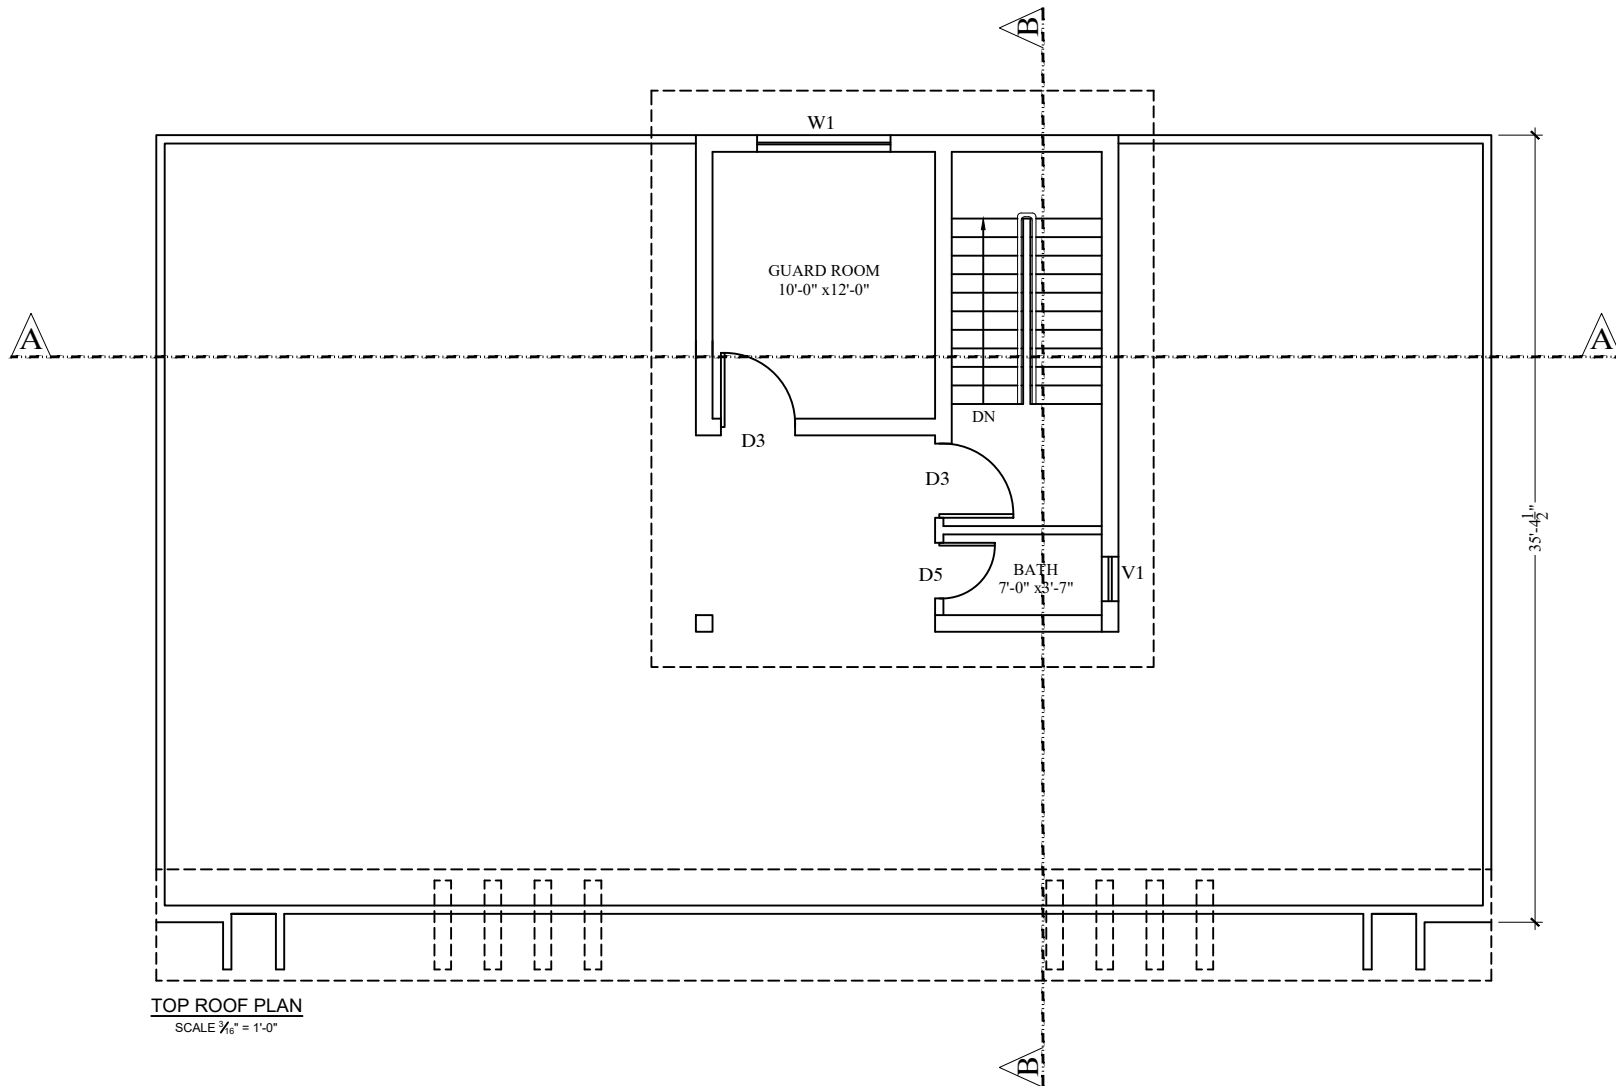

PAK
CONSULTING ENGINEERS

ENGINEER:-
PAK CONSULTING ENGINEERS
CHIB PLAZA COMMERCIAL AREA
CHAKLALA SCHEME III RAWALPINDI
Email: pakconsultingengineers@gmail.com

DRAWN BY
APPROVED BY


GHULAM MURTAZA
BABAR TANWIR

PROJECT:-
PMU, PAKISTAN DIGITAL
CITY HARIPUR KP
DATE:
SCALE: N.T.S.

DRAWING NO.:-
02

TITLE:-
TOP ROOF PLAN
SUB TITLE:-
LAYOUT PLAN

REV No.	DATE	REVISIONS
1		
2		
3		
4		
5		

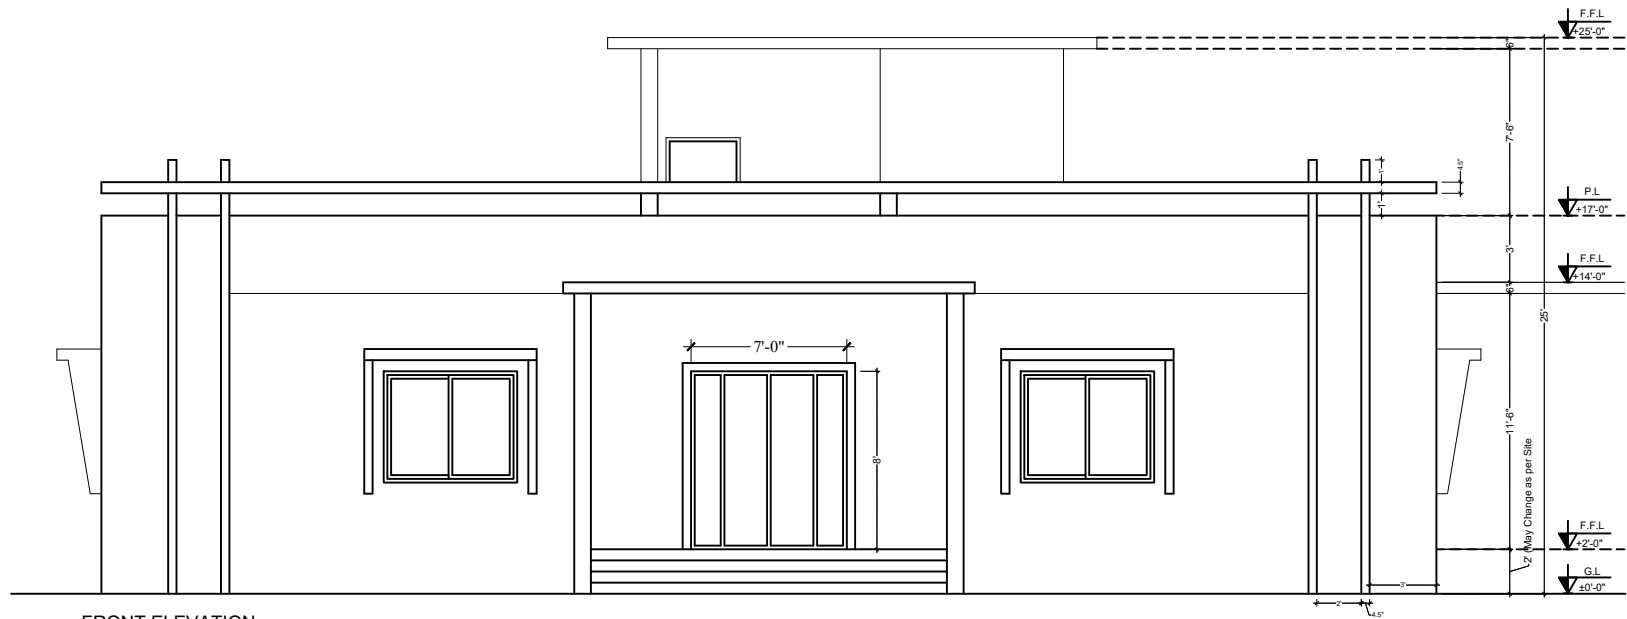

FRONT ELEVATION
SCALE 1/8" = 1'-0"

PAK
CONSULTING ENGINEERS

ENGINEER:-
PAK CONSULTING ENGINEERS
CHIB PLAZA COMMERCIAL AREA
CHAKLALA SCHEME III RAWALPINDI
Email:pakconsultingengineers@gmail.com


DRAWN BY
APPROVED BY

GHULAM MURTAZA
BABAR TANWIR

PROJECT:-
PMU, PAKISTAN DIGITAL
CITY HARIPUR KP
DATE:
SCALE N.T.S.
DRAWING NO:-
03

TITLE:-
FRONT ELEVATION
SUB TITLE:-
ELEVATION

REV No.	DATE	REVISIONS
1		
2		
3		
4		
5		

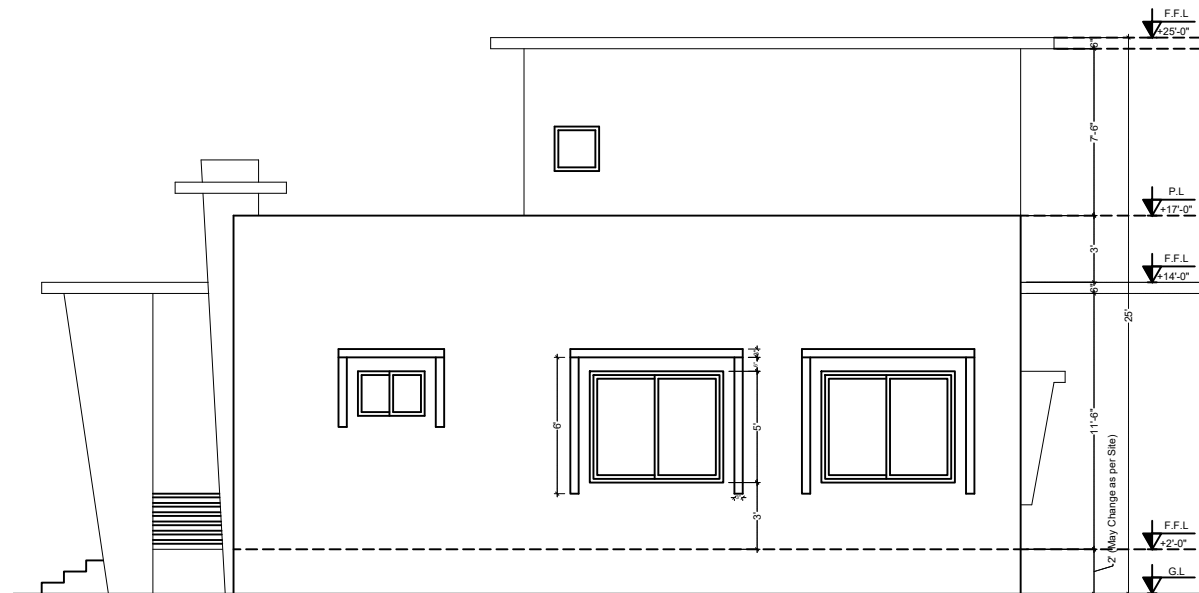

RIGHT SIDE ELEVATION
SCALE $\frac{1}{8}" = 1'-0"$

PAK
CONSULTING ENGINEERS

ENGINEER:-
PAK CONSULTING ENGINEERS
CHIB PLAZA COMMERCIAL AREA
CHAKLALA SCHEME III RAWALPINDI
Email: pakconsultingengineers@gmail.com

DRAWN BY
APPROVED BY

GHULAM MURTAZA
BABAR TANWIR


PROJECT:-
PMU, PAKISTAN DIGITAL
CITY HARIPUR KP

DATE:
SCALE N.T.S.

DRAWING NO.:-
04

TITEL:-
RIGHT SIDE ELEVATION
SUB TITEL:-
ELEVATION

REV No.	DATE	REVISIONS
1		
2		
3		
4		
5		

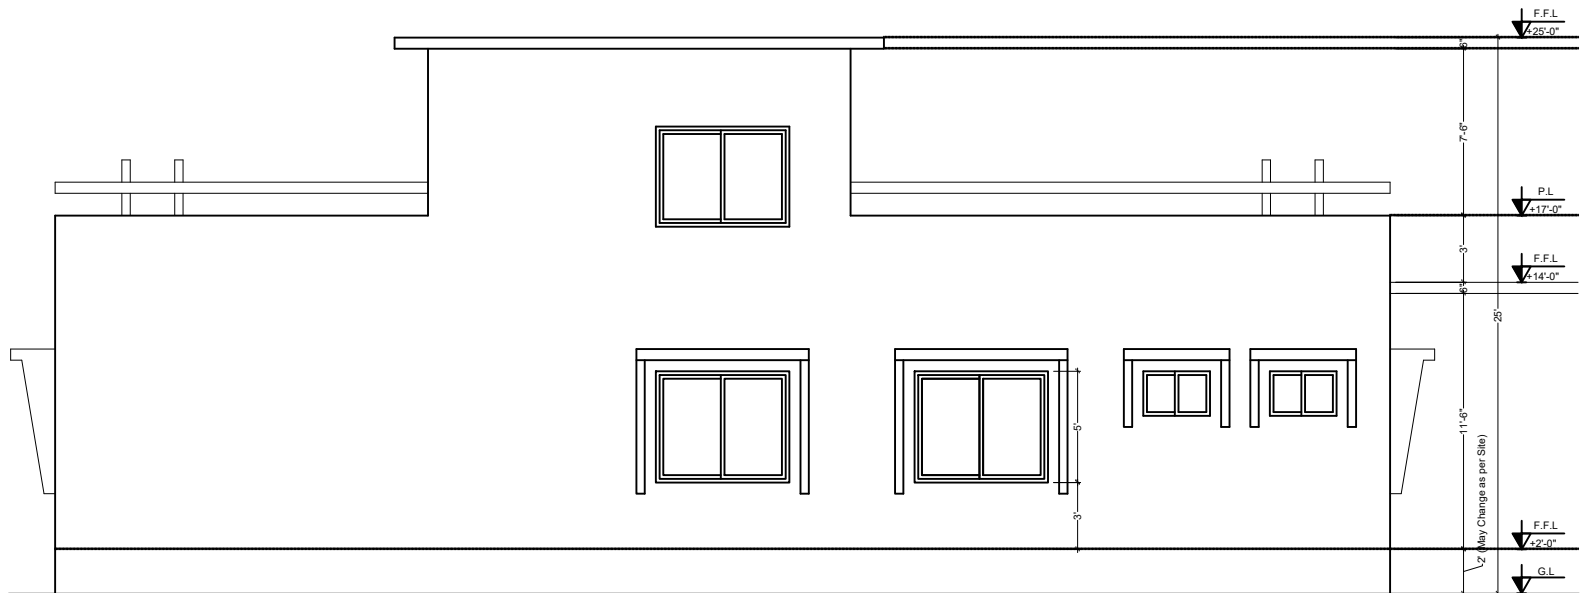

REAR ELEVATION
SCALE $\frac{3}{8}" = 1'-0"$

PAK
CONSULTING ENGINEERS

ENGINEER:-
PAK CONSULTING ENGINEERS
CHIB PLAZA COMMERCIAL AREA
CHAKLALA SCHEME III RAWALPINDI
Email: pakconsultingengineers@gmail.com

DRAWN BY
APPROVED BY


GHULAM MURTAZA
BABAR TANWIR

PROJECT:-
PMU, PAKISTAN DIGITAL
CITY HARIPUR KP
DATE:
SCALE: N.T.S.

DRAWING NO.:-
05

TITLE:-
BACK SIDE ELEVATION
SUB TITLE:-
ELEVATION

REV No.	DATE	REVISIONS
1		
2		
3		
4		
5		

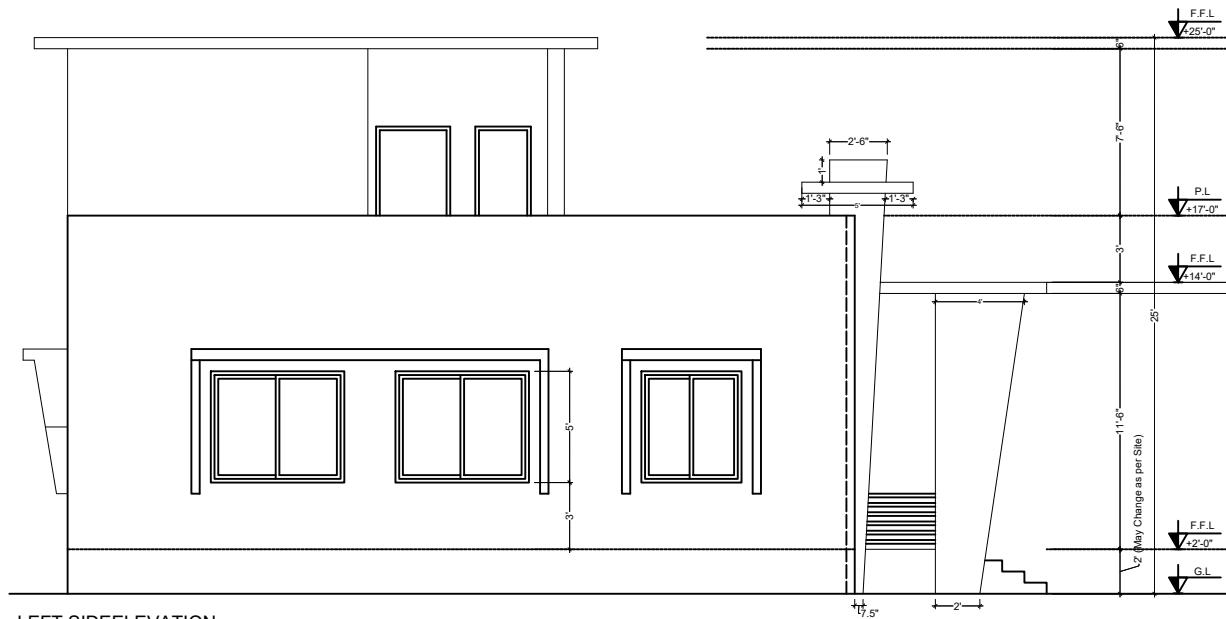

LEFT SIDE ELEVATION
SCALE 3/8" = 1'-0"

PAK
CONSULTING ENGINEERS

ENGINEER:-
PAK CONSULTING ENGINEERS
CHIB PLAZA COMMERCIAL AREA
CHAKLALA SCHEME III RAWALPINDI
Email: pakconsultingengineers@gmail.com

DRAWN BY
APPROVED BY


GHULAM MURTAZA
BABAR TANWIR

PROJECT:-
PMU, PAKISTAN DIGITAL
CITY HARIPUR KP
DATE:
SCALE: N.T.S.

DRAWING NO:-
06

TITLE:-
LEFT SIDE ELEVATION
SUB TITLE:-
ELEVATION

REV No.	DATE	REVISIONS
1		
2		
3		
4		
5		

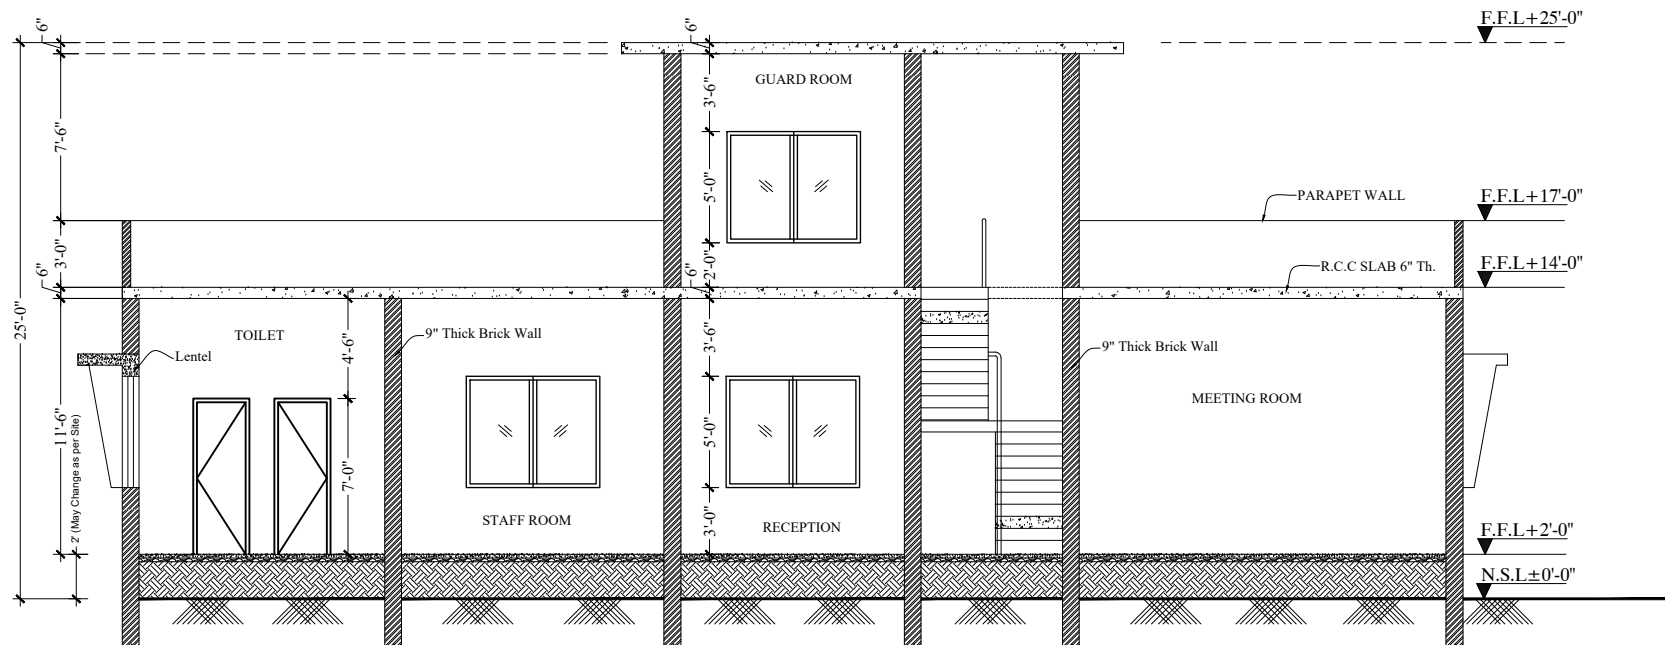

SECTION A-A

SCALE : 1/8" = 1'

PAK
CONSULTING ENGINEERS

ENGINEER:-
PAK CONSULTING ENGINEERS
CHIB PLAZA COMMERCIAL AREA
CHAKLALA SCHEME III RAWALPINDI
Email: pakconsultingengineers@gmail.com

DRAWN BY
APPROVED BY

GHULAM MURTAZA
BABAR TANWIR


PROJECT:-
PMU, PAKISTAN DIGITAL
CITY HARIPUR KP

DATE: _____
SCALE: N.T.S.

DRAWING NO.:-
07

TITLE:-
SECTION A-A
SUB TITLE:-
SECTION

REV No.	DATE	REVISIONS
1		
2		
3		
4		
5		

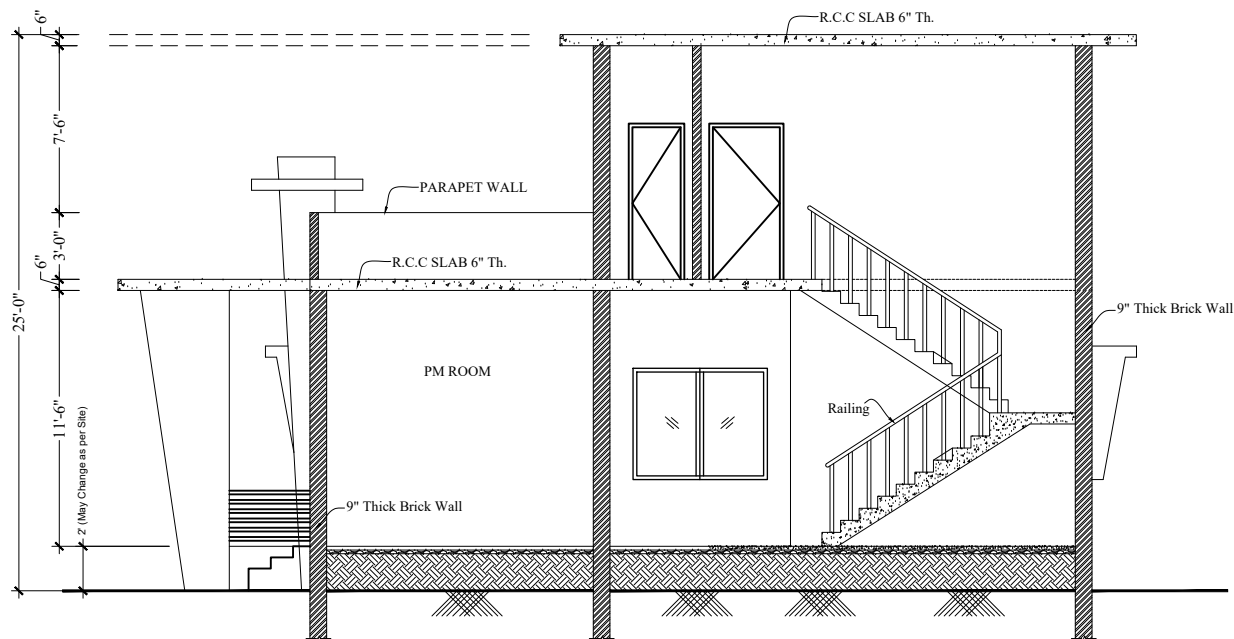

SECTION B-B

SCALE : 1/8" = 1'

PAK
CONSULTING ENGINEERS

ENGINEER:-
PAK CONSULTING ENGINEERS
CHIB PLAZA COMMERCIAL AREA
CHAKLALA SCHEME III RAWALPINDI
Email:pakconsultingengineers@gmail.com

DRAWN BY

GHULAM MURTAZA

APPROVED BY

BABAR TANWIR

PROJECT:-
PMU, PAKISTAN DIGITAL
CITY HARIPUR KP

DATE:

DRAWING NO.:-


08

SCALE


N.T.S

TITLE:-
SECTION B-B
SUB TITLE:-
ELEVATION


REV No.	DATE	REVISIONS
1		
2		
3		
4		
5		

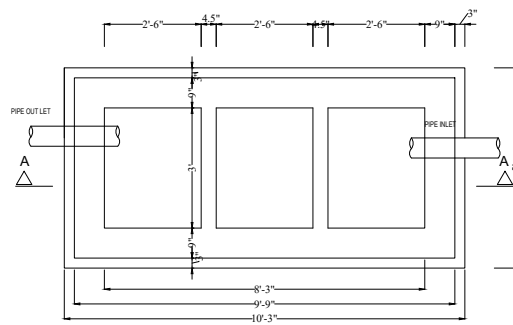


PLAN OF SEPTIC TANK

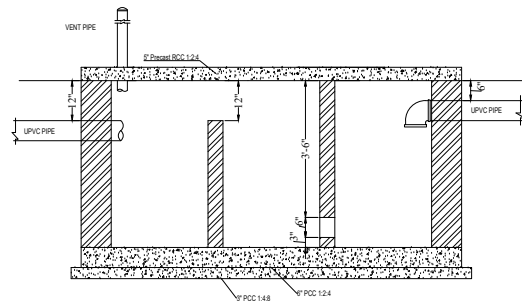

SECTION A-A

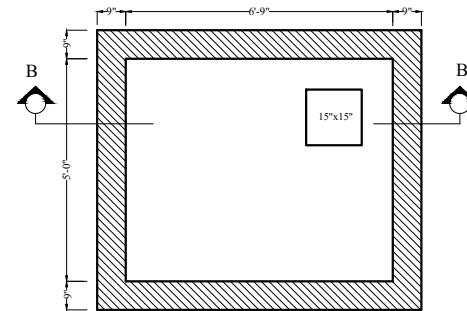

PLAN OF O.H.W. TANK
(1000 US-GALLONS)

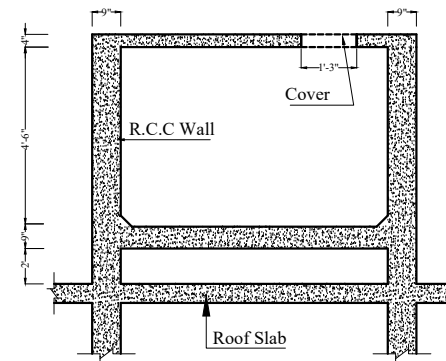

SECTION B-B

PAK
CONSULTING ENGINEERS

ENGINEER:-
PAK CONSULTING ENGINEERS
CHIB PLAZA COMMERCIAL AREA
CHAKLALA SCHEME III RAWALPINDI
Email:pakconsultingengineers@gmail.com

DRAWN BY
APPROVED BY

GHULAM MURTAZA
BABAR TANWIR


PROJECT:-
PMU, PAKISTAN DIGITAL
CITY HARIPUR KP

DATE:
SCALE

DRAWING NO:-
09


TITLE:-
SEPTIC TANK & O.H.W. TANK
SUB TITLE:-
DETAILS

REV	No.	DATE	REVISIONS
1			
2			
3			
4			
5			

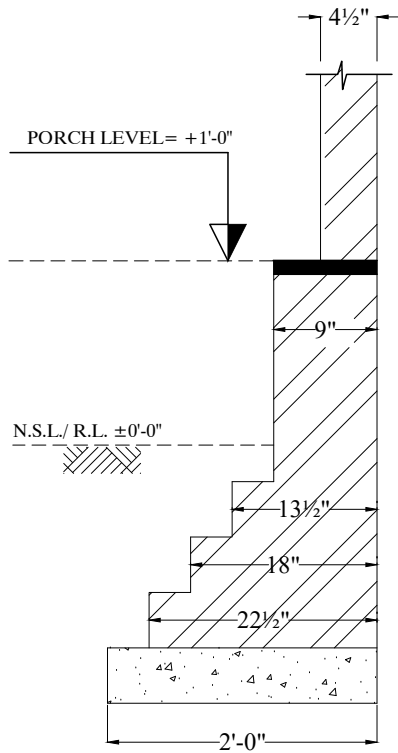


Section of
Boundary Wall

Scale: NTS

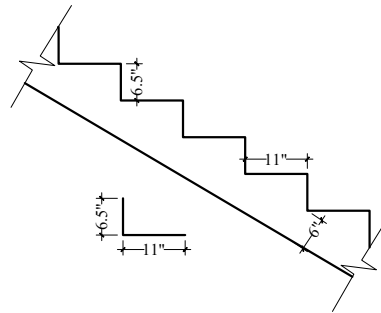

TYPICAL DETAILS OF STAIRS

Scale: NTS

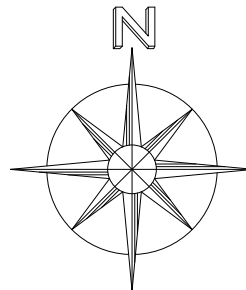

NORTH
Scale: NTS

SCHEDULE OF AREA

GROUND FLOOR COVERED AREA	= 2154.00 SQFT
FIRST FLOOR COVERED AREA	= 289 SQFT
GRAND TOTAL	= 2443.00 SQFT

SCHEDULE OF OPENINGS

S.no	TYPE	SIZE
1	D1	7'-0" X 8'-0"
2	D2	4'-0" X 7'-0"
3	D3	3'-6" X 7'-0"
4	D4	3'-0" X 7'-0"
5	D5	2'-6" X 7'-0"
6	W1	6'-0" X 5'-0"
6	W2	4'-0" X 5'-0"
6	V1	2'-0" X 2'-0"

PAK
CONSULTING ENGINEERS

ENGINEER:-
PAK CONSULTING ENGINEERS
CHIB PLAZA COMMERCIAL AREA
CHAKLALA SCHEME III RAWALPINDI
Email: pakconsultingengineers@gmail.com

DRAWN BY
APPROVED BY

GHULAM MURTAZA

BABAR TANWIR

PROJECT:-
PMU, PAKISTAN DIGITAL
CITY HARIPUR KP

DATE:
SCALE: N.T.S.

DRAWING NO:-
10

TITLE:-

SUB TITLE:-

DETAILS

REV No.	DATE	REVISIONS
1		
2		
3		
4		
5		